


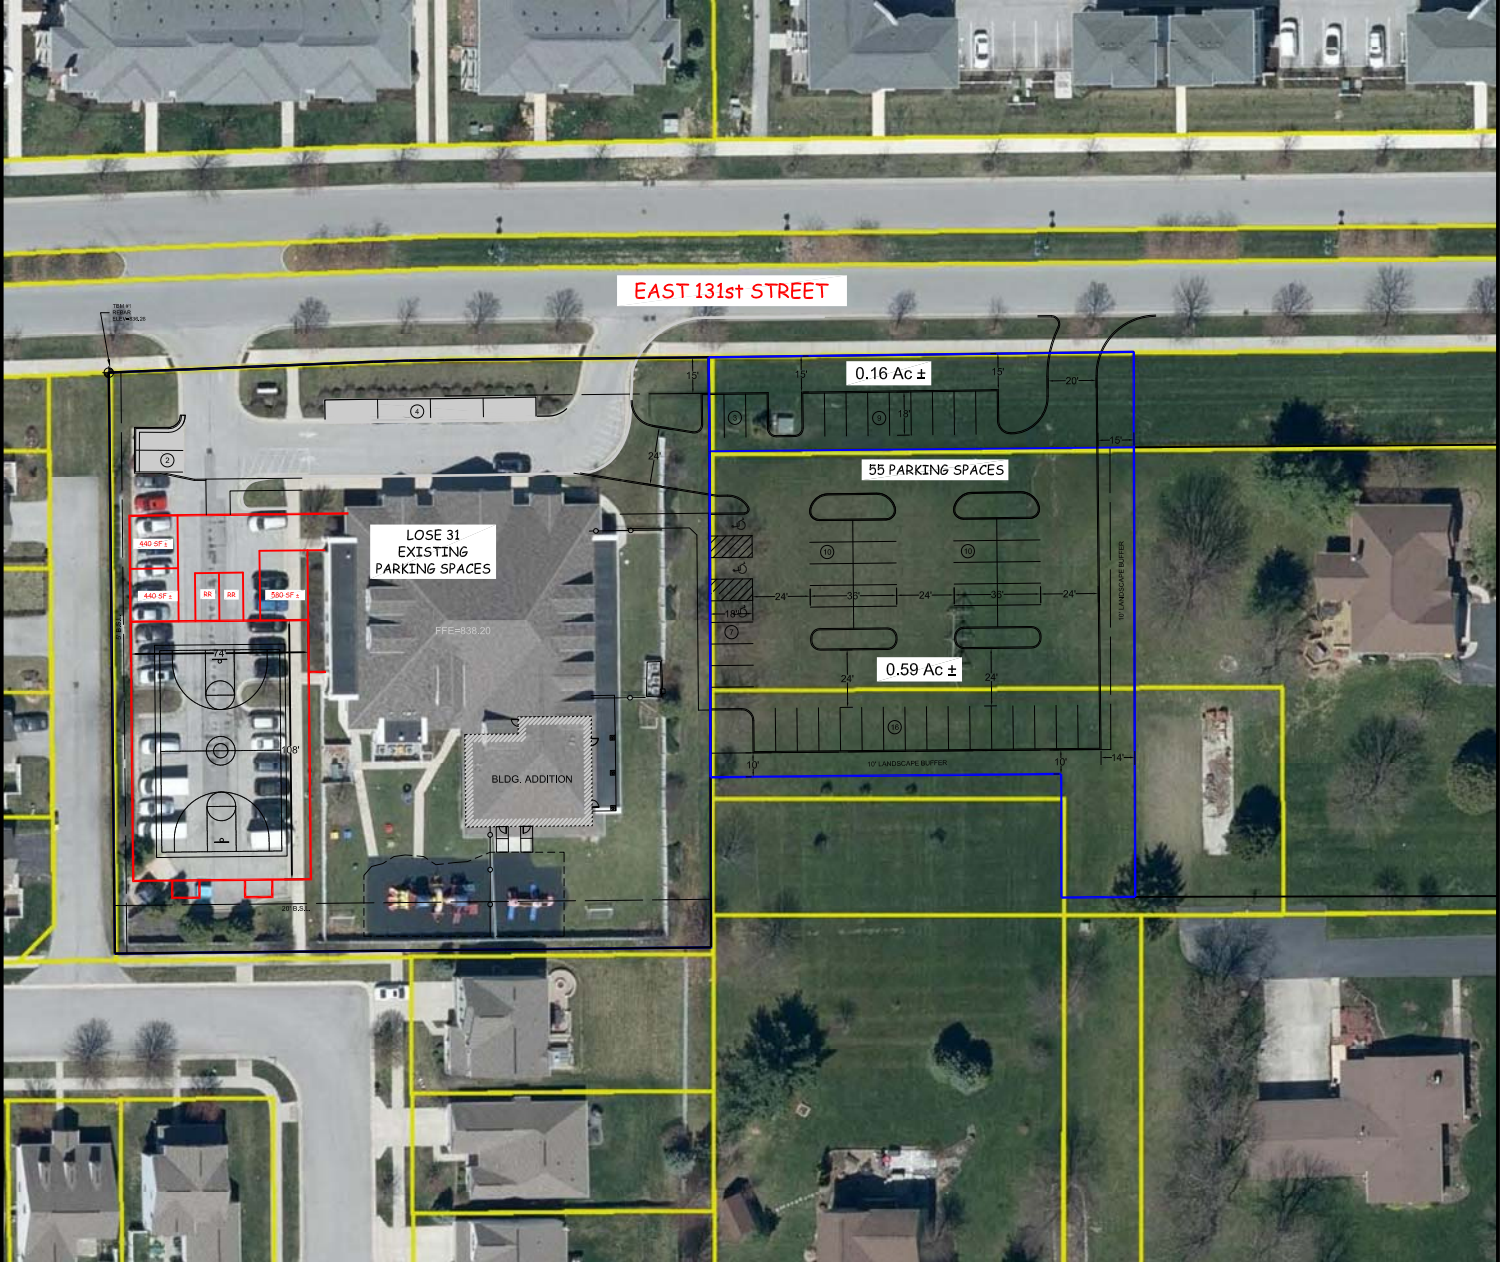

CONCEPT SITE PLAN



PLAYSCHOOL AT SAXONY VILLAGE
13149 EAST 131ST STREET, FISHERS, INDIANA

LAYOUT-6

CSG PROJECT NUMBER TPS.008	DATE: 12/14/20 DWN. BY: BSC	CIVIL SITE GROUP, INC. 160 WEST CARMEL DRIVE, SUITE 240 CARMEL, INDIANA 46032 (317) 810-1677 - www.civilsite.net	
SHEET 1 OF 1	CHKD. BY: BSC SCALE: 1" = 80'		